


AVONDALE COURT


LAKE ONTARIO



AST1  
LUMINAIRE TYPES P1 & P2

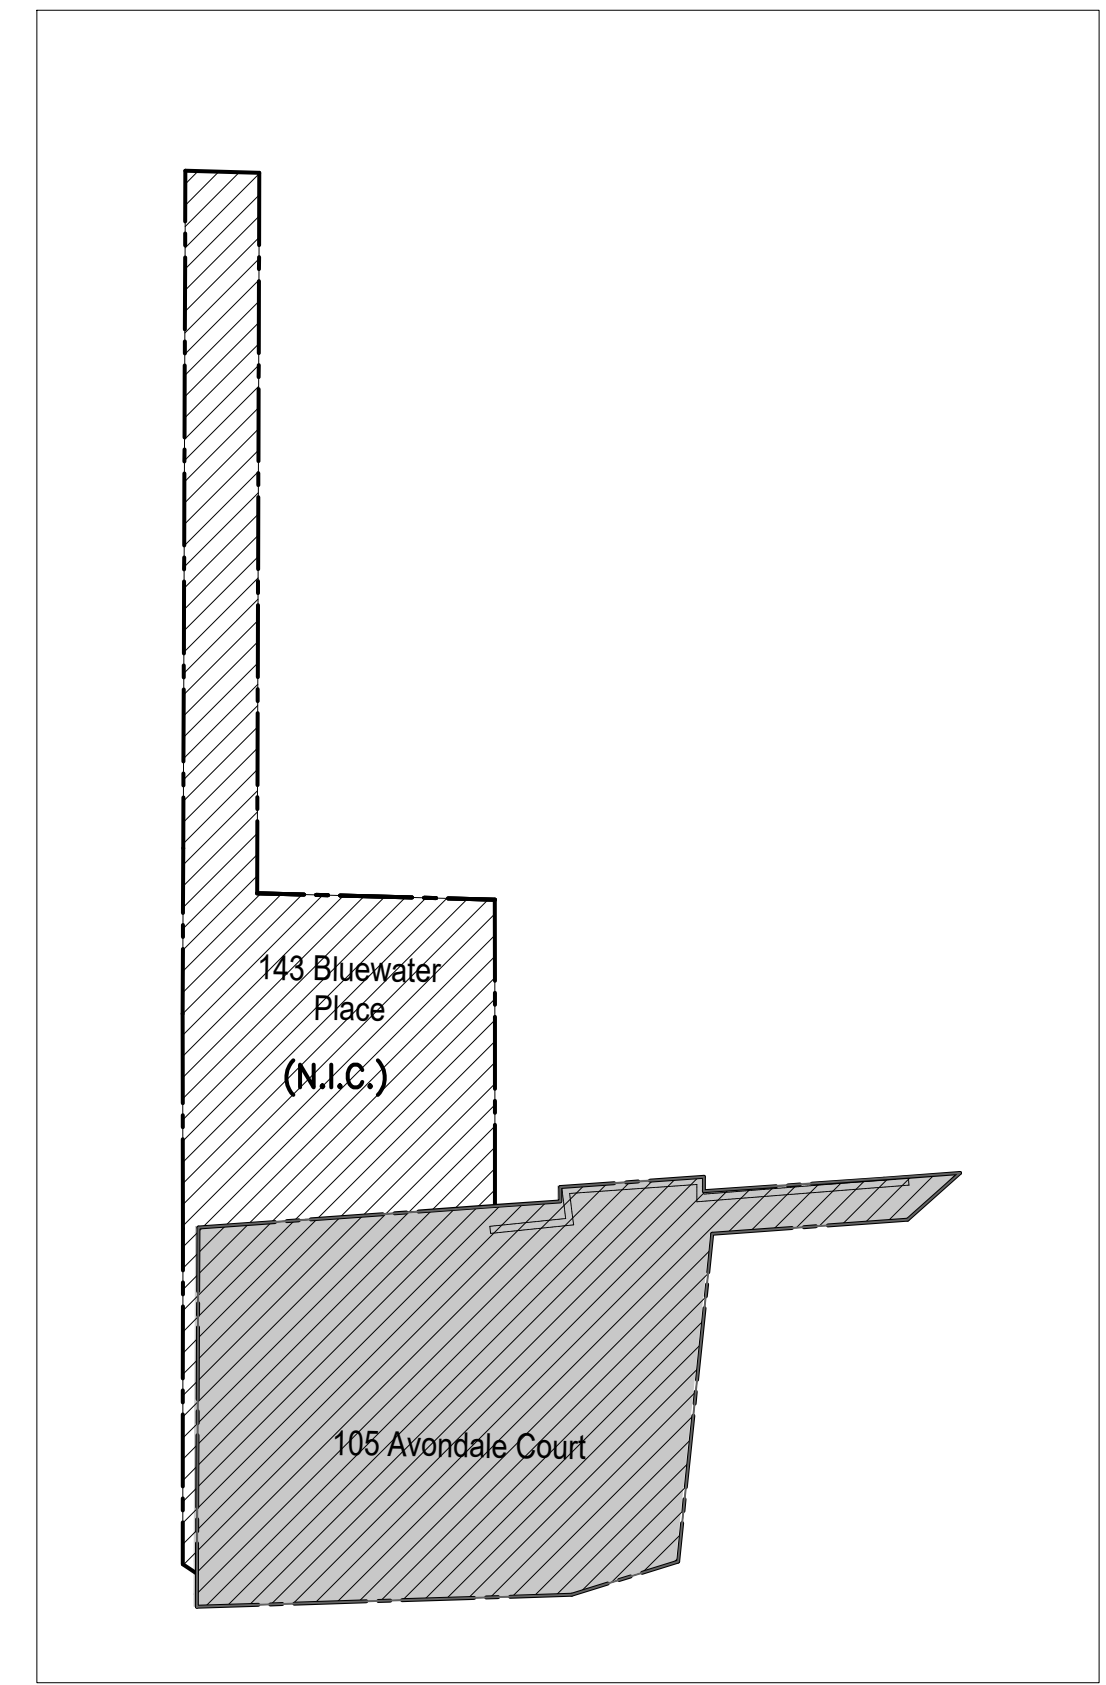


KEY PLAN  
SCALE: NTS

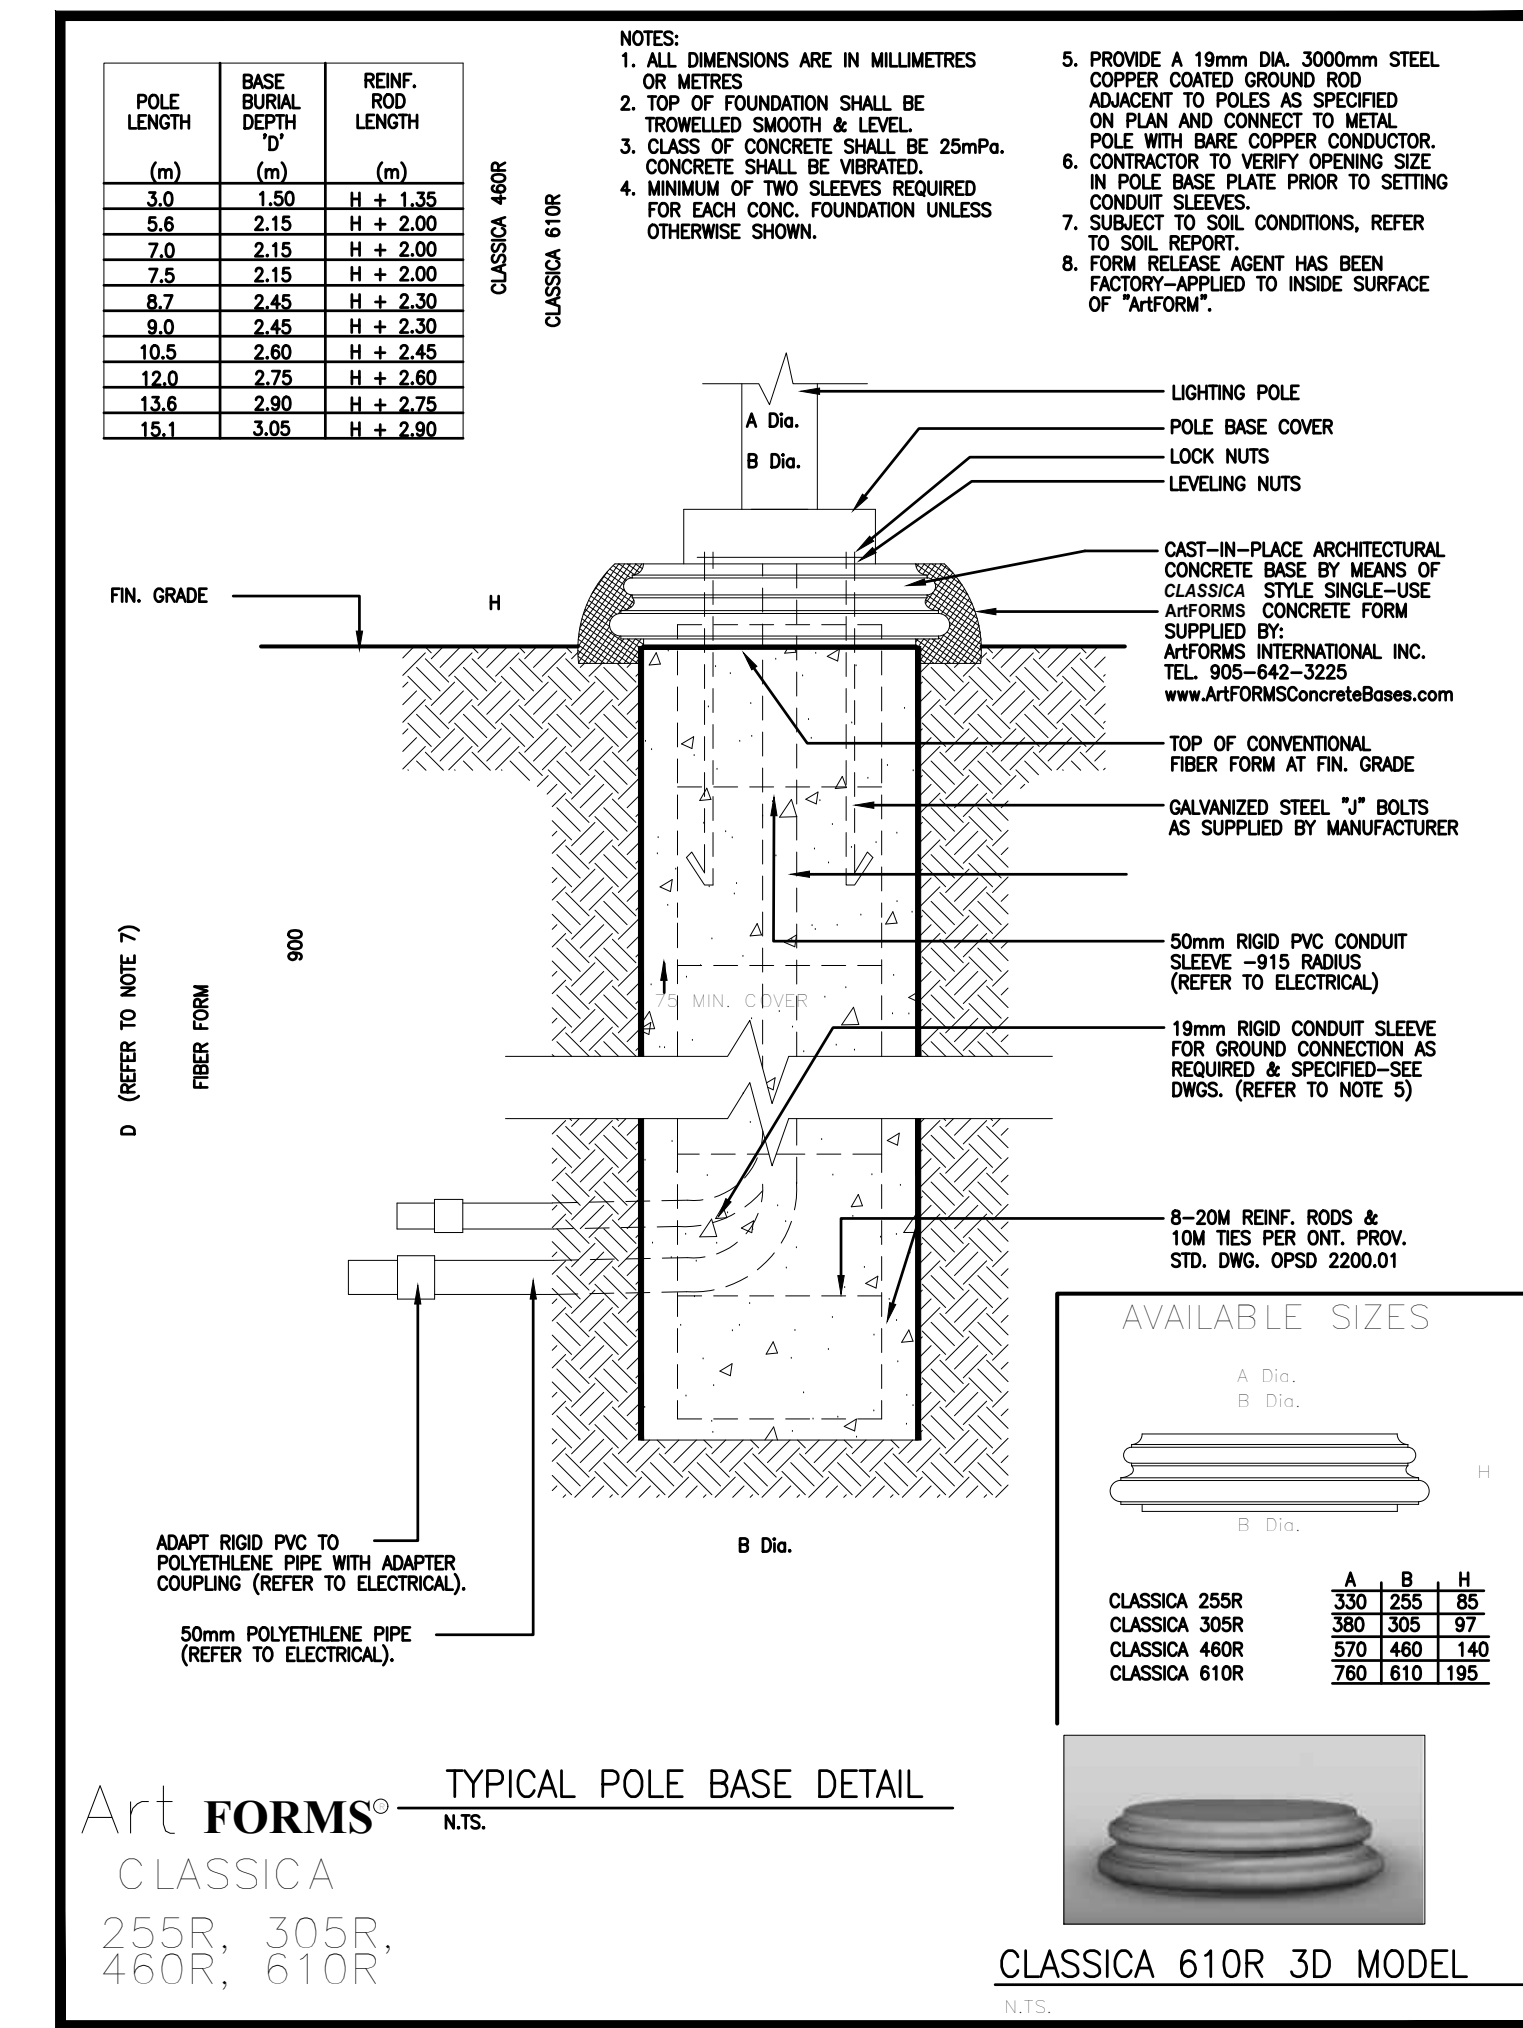

Luminaire Schedule						
Symbol	Qty	Label	Lum. Lumens	LLF	Lum. Watts	Description [MANUFAC]
⊙	6	P1	4401	0.900	50	AST1-1-LG4500-R2-40-120-DS Selux Corporation
⊙	3	P2	4219	0.900	50	AST1-1-LG4500-R3-40-120-DS Selux Corporation

Calculation Summary								
Label	CalcType	Units	Avg	Max	Min	Avg/Min	Max/Min	LVRatio
Street A Block 1-2-4 Lumiance	Luminance	Cd/Sq.m	0.64	1.4	0.2	3.20	7.00	N.A.
Street A Block 1-2-4 Veil Lum	Veiling Luminance	Cd/Sq.m	0.00	0.0	0.0	N.A.	N.A.	0.00
Street A Block 9	Illuminance	Lux	12.66	25.4	4.1	3.09	6.20	N.A.
Street A Block 9-1	Illuminance	Lux	13.52	25.5	4.2	3.22	6.07	N.A.
Street A Block 9 Lumiance	Luminance	Cd/Sq.m	0.60	2.0	0.2	3.00	10.00	N.A.
Street A Block 9 Veil Lum	Veiling Luminance	Cd/Sq.m	0.03	0.2	0.0	N.A.	N.A.	0.33

MANUEL JORDAO & ASSOCIATES LTD.  
ELECTRICAL ENGINEERING  
556 EDWARD AVENUE, UNIT 82  
RICHMOND HILL, ONTARIO, L4C 9Y5 CANADA  
PHONE: (905) 780-8590 FAX: (905) 780-8591  
Email: mjordao@mjaeng.com

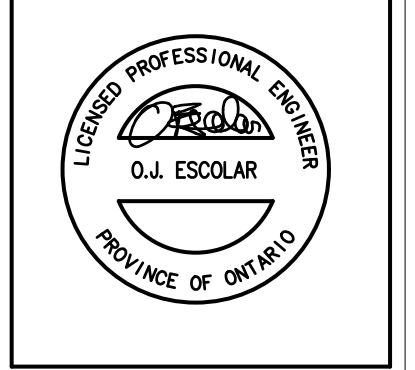

THIS DOCUMENT SHALL REMAIN THE PROPERTY OF MANUEL JORDAO & ASSOCIATES LTD. THE CLIENT SHALL BE PERMITTED TO RETAIN COPIES FOR INFORMATION AND REFERENCE ONLY. THIS DOCUMENT CANNOT BE MODIFIED AND/OR REPRODUCED BY OTHERS WITHOUT WRITTEN CONSENT OF MANUEL JORDAO & ASSOCIATES LTD.

No.	Revisions	Date
1	ISSUED FOR SPA	MAY 11 2017
2	Issue	DATE

PROPOSED  
AVONDALE TOWNHOMES  
FIRST URBAN  
105 AVONDALE COURT  
BURLINGTON, ONTARIO

job no. 2017-104  
dwg. file  
dwn. by RF  
scale SHOWN  
date MAR 2017  
dwg. title  
SITE PLAN