
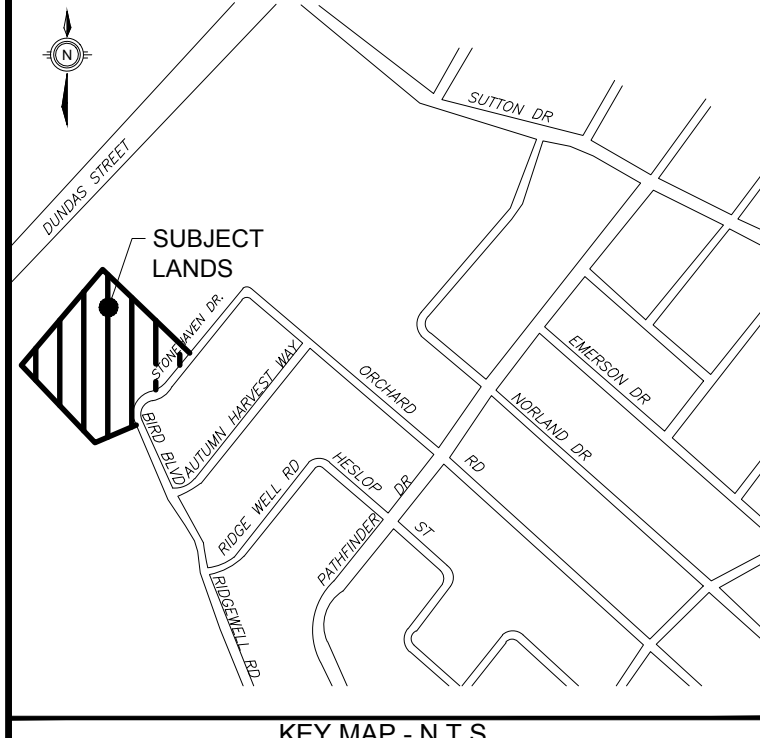


14.0m ROAD ALLOWANCE
SCALE: N.T.S.
7.5m PAVEMENT

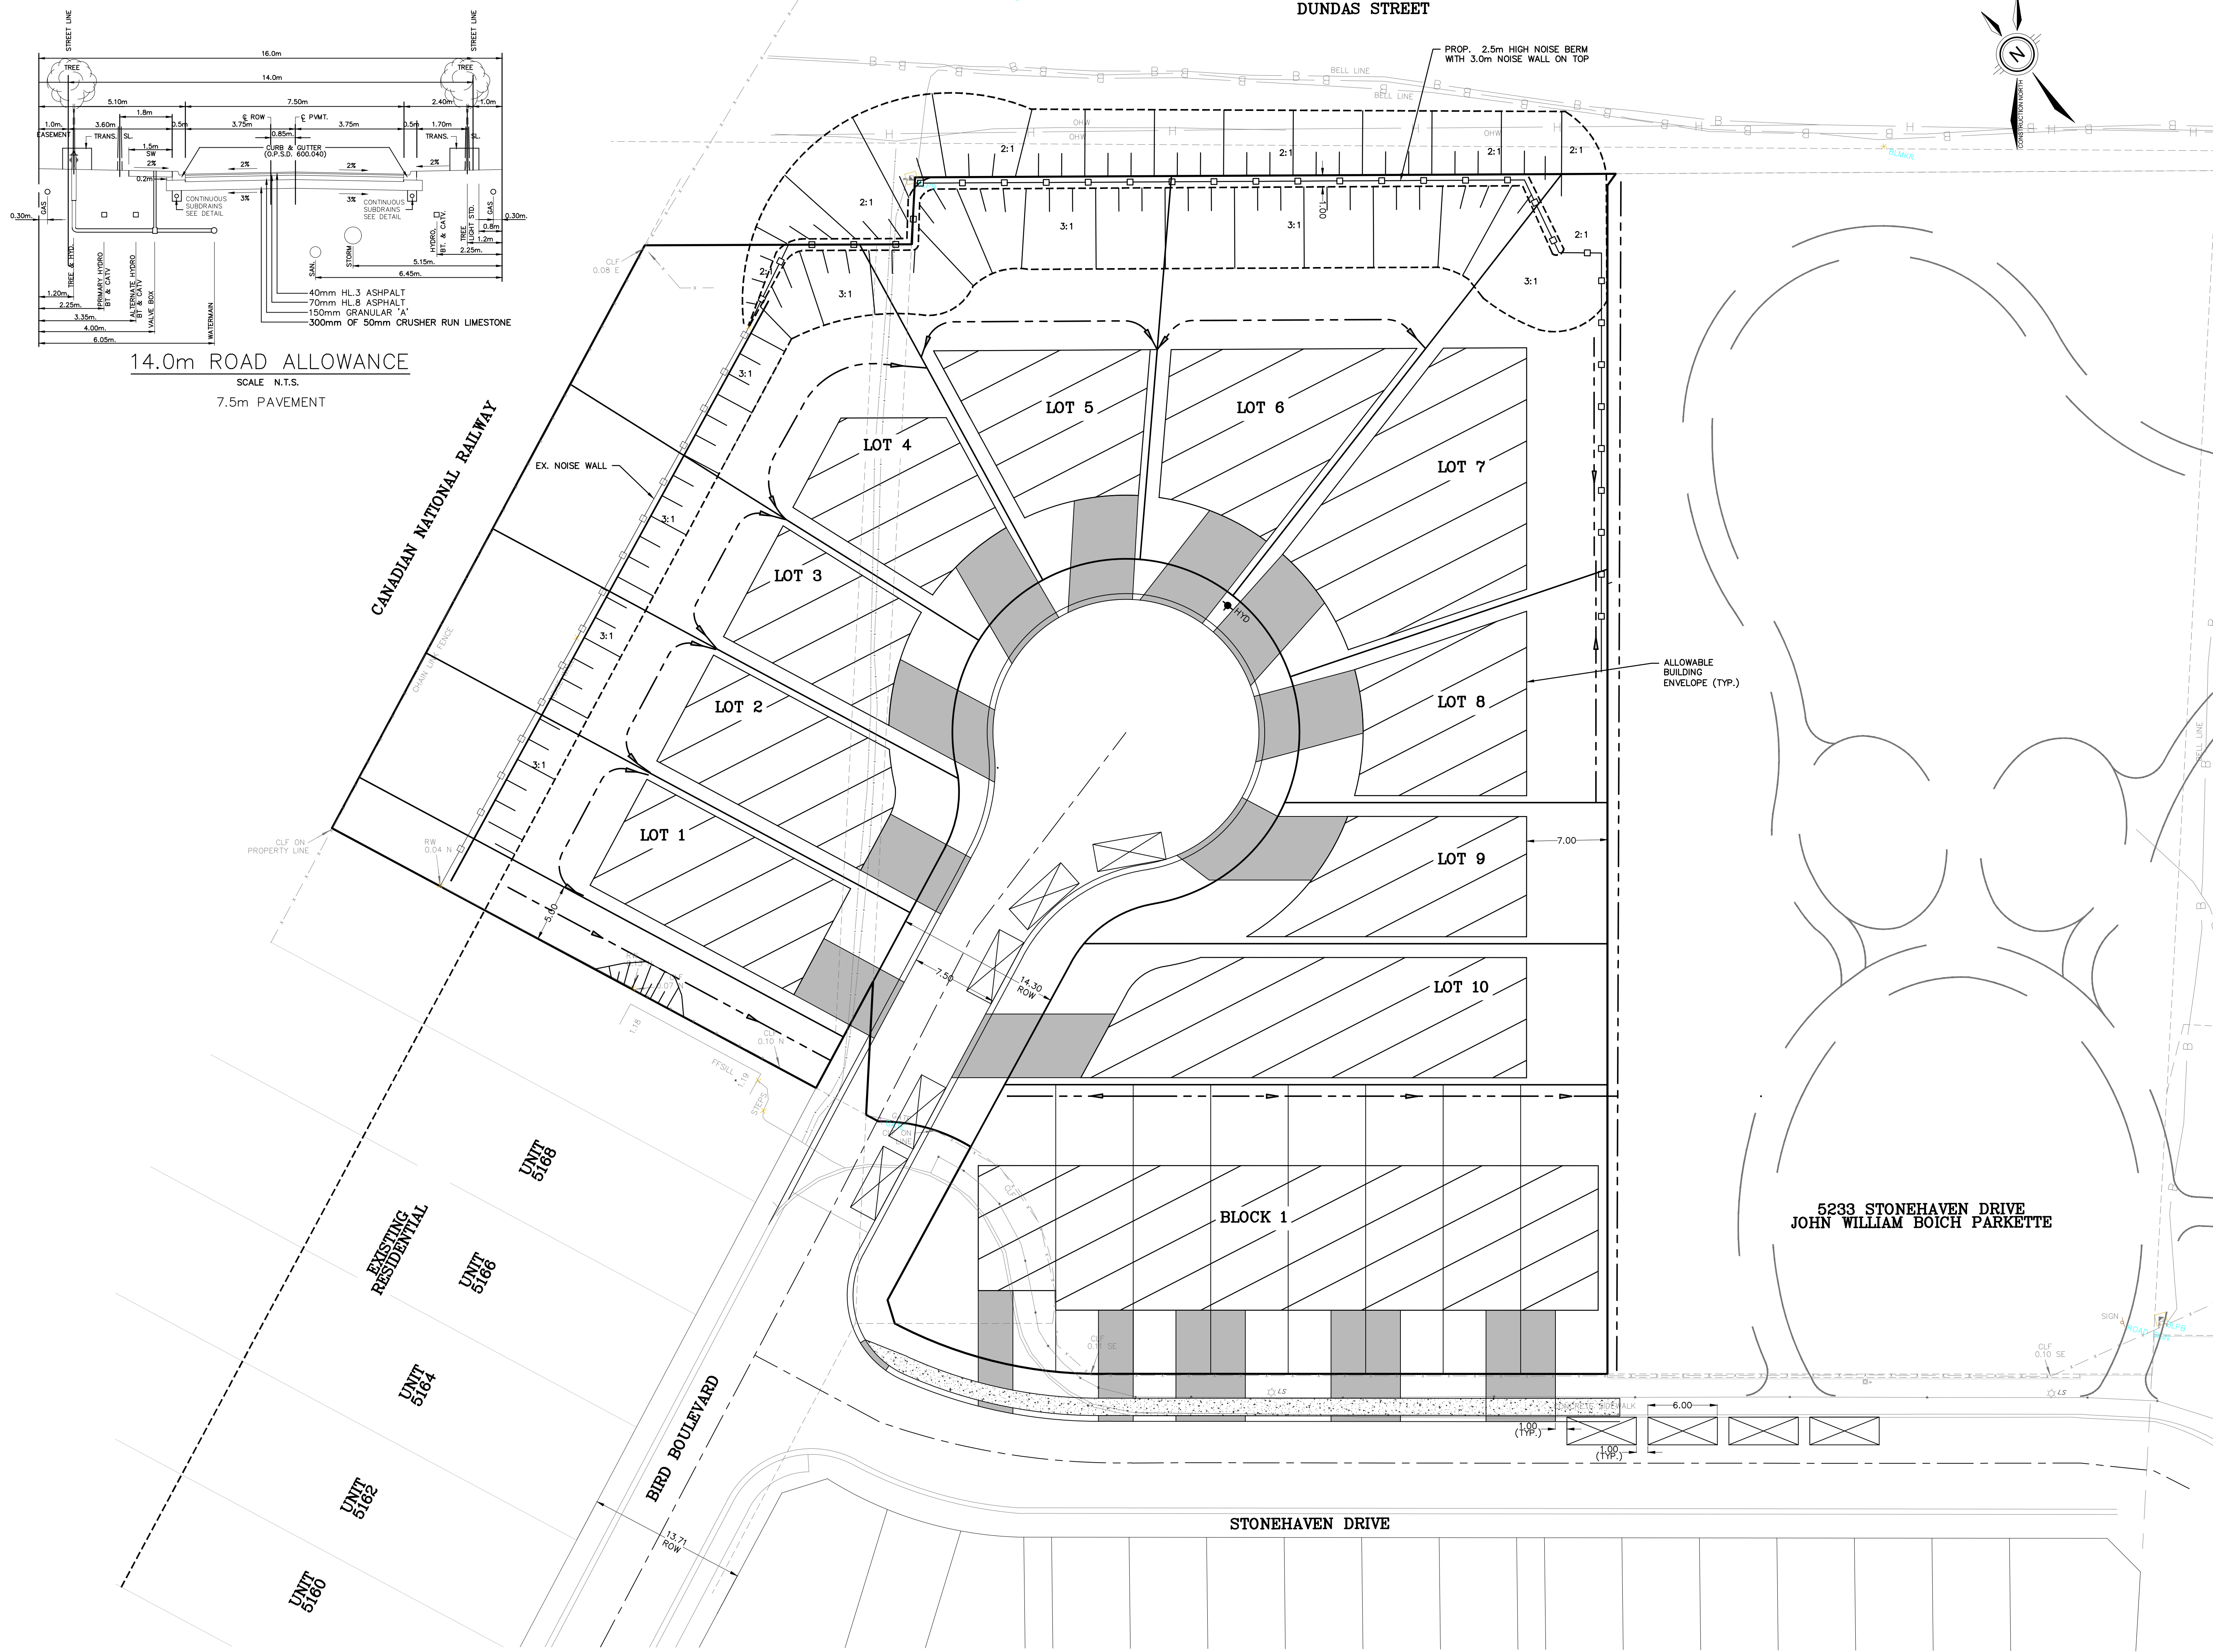


- KEY MAP - N.T.S.
- LEGEND**
- 6.0x2.4m STREET PARKING
 - PROPOSED FIRE HYDRANT
 - EXISTING HYDRANT
 - TRANSFORMER LOCATION
 - STREETLIGHT PEDESTAL LOCATION
 - BELL BOX
 - CABLE TV BOX
 - PROPOSED LIGHT STANDARD SEE ELECTRICAL PLAN E-110
 - PROPOSED STOP SIGN

NOT FOR CONSTRUCTION

SOURCE:
- TOPOGRAPHIC SURVEY INFORMATION OBTAINED BY MACKAY MACKAY & PETERS LIMITED, DRAWING NO. 17-092
- JOHN WILLIAM BOICH PARKETTE GRADING AND SERVING INFORMATION OBTAINED BY A.J. CLARKE AND ASSOCIATES LTD.

BENCHMARK:
- CITY OF BURLINGTON BENCHMARK NO. 443
ELEVATION = 152.321m (GGVD-1928: 1978 ADJUSTMENT)
MTO BM PLAQUE 818102 SET ON TOP OF CONCRETE BOX CULVERT LOCATED ON SOUTHEAST CORNER OF APPELBY LINE AND DUNDAS STREET.

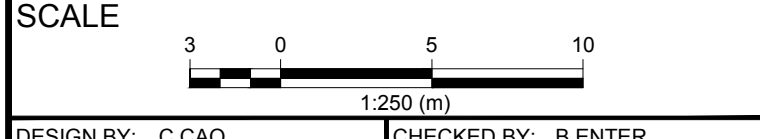

DESIGN BY: C.CAO CHECKED BY: B.ENTER
DRAWN BY: C.CAO DATE: 2017-05-24

NO.	DATE	BY	DESCRIPTION
0	2017-06-29	C.C.	FUNCTIONAL SERVICES REPORT
1			

DRAWING ISSUE RECORD

NO.	DATE	BY	DESCRIPTION

APPROVALS

IBI GROUP
200 East Wing-360 James Street North
Hamilton ON L8L 1H5 Canada
tel 905 546 1010 fax 905 546 1011
ibigroup.com

**CITY OF BURLINGTON
REGION OF HALTON**

**5209 STONEHAVEN DRIVE
MANTELLA CORPORATION**

ON-STREET PARKING PLAN

FILE NUMBER: 105842 SHEET NUMBER: OPP